



ADDENDUM NO. 1
March 18, 2024

MEADOWLANDS WET WELL REPLACEMENT AND BYPASS

ITEM NO. 1:

FRONT END DOCUMENTS - BID SCHEDULE

Additive Alternate Bid Item A1:

ITEM NO.	ADDITIVE ALTERNATE ITEM	QUANTITY AND UNIT	UNIT PRICE	AMOUNT
A1	Remove and Replace Irrigation Facilities	1 LS	\$	\$

SECTION 01 22 00 – EXPLANATION OF BID ITEMS

Bid Item A1 – Irrigation Facilities: Payment under this item shall be considered full compensation for all labor, materials, tools, equipment and incidentals required to remove and replace Irrigation lines and facilities necessary to complete construction in kind.

SHEET C2 OF PLANSET

Drawing C2 shows the location of where the irrigation facilities to be removed and replaced in-kind are located.

ITEM NO. 2:

FRONT END DOCUMENTS - BID SCHEDULE

Additive Alternate Bid Item A2:

ITEM NO.	ADDITIVE ALTERNATE ITEM	QUANTITY AND UNIT	UNIT PRICE	AMOUNT
A2	Dry Well Concrete Leveling and Reseal	1 LS	\$	\$

SECTION 01 22 00 – EXPLANATION OF BID ITEMS

Bid Item A2 – Dry Well Concrete Leveling and Re-seal: Payment under this item shall be considered full compensation for all labor, materials, tools, equipment and incidentals required to level the concrete at the base of the dry well and re-sealing the discharge pipe at the location where it exits the dry well.

SHEET C3 OF PLANSET

Drawing C3 shows a section view of the dry well and indicates the concrete base of the dry well to be leveled along with the location of where the discharge pipe is to be re-sealed.

ITEM NO. 3:

SHEET E2.1 OF PLANSET

Drawing E2.1 has updates to amperage and voltage shown in the single line diagram.

ITEM NO. 4:

RESPONSE TO QUESTIONS & CLARIFICATIONS

1. What time of day do peak sanitary sewer flow rates occur.

Response: The flow at the West I Street Sewer Lift Station are highest at approximately 10:00 AM and 6:00 PM.

2. Is there an engineer's estimate for the project?

Response: The estimate for the project is \$500,000 to \$640,000.

This Addendum forms a part of the Proposal Documents and will be incorporated into the Contract Documents, as applicable. All other conditions of the Contract Documents remain unchanged. The following changes, additions, or deletions as set forth herein shall apply to the Contract Documents and shall be made a part thereof and shall be subject to all the requirements thereof as through originally shown and/or specified.

Proposals shall be submitted in accordance with this Addendum. All consultants **MUST** acknowledge receipt of this Addendum by signing and returning this Addendum with your Proposal.

City of Los Banos

Firm Name: _____


By: _____

Title: _____

Date: _____



By: Jelene de Melo
Admin Coordinator

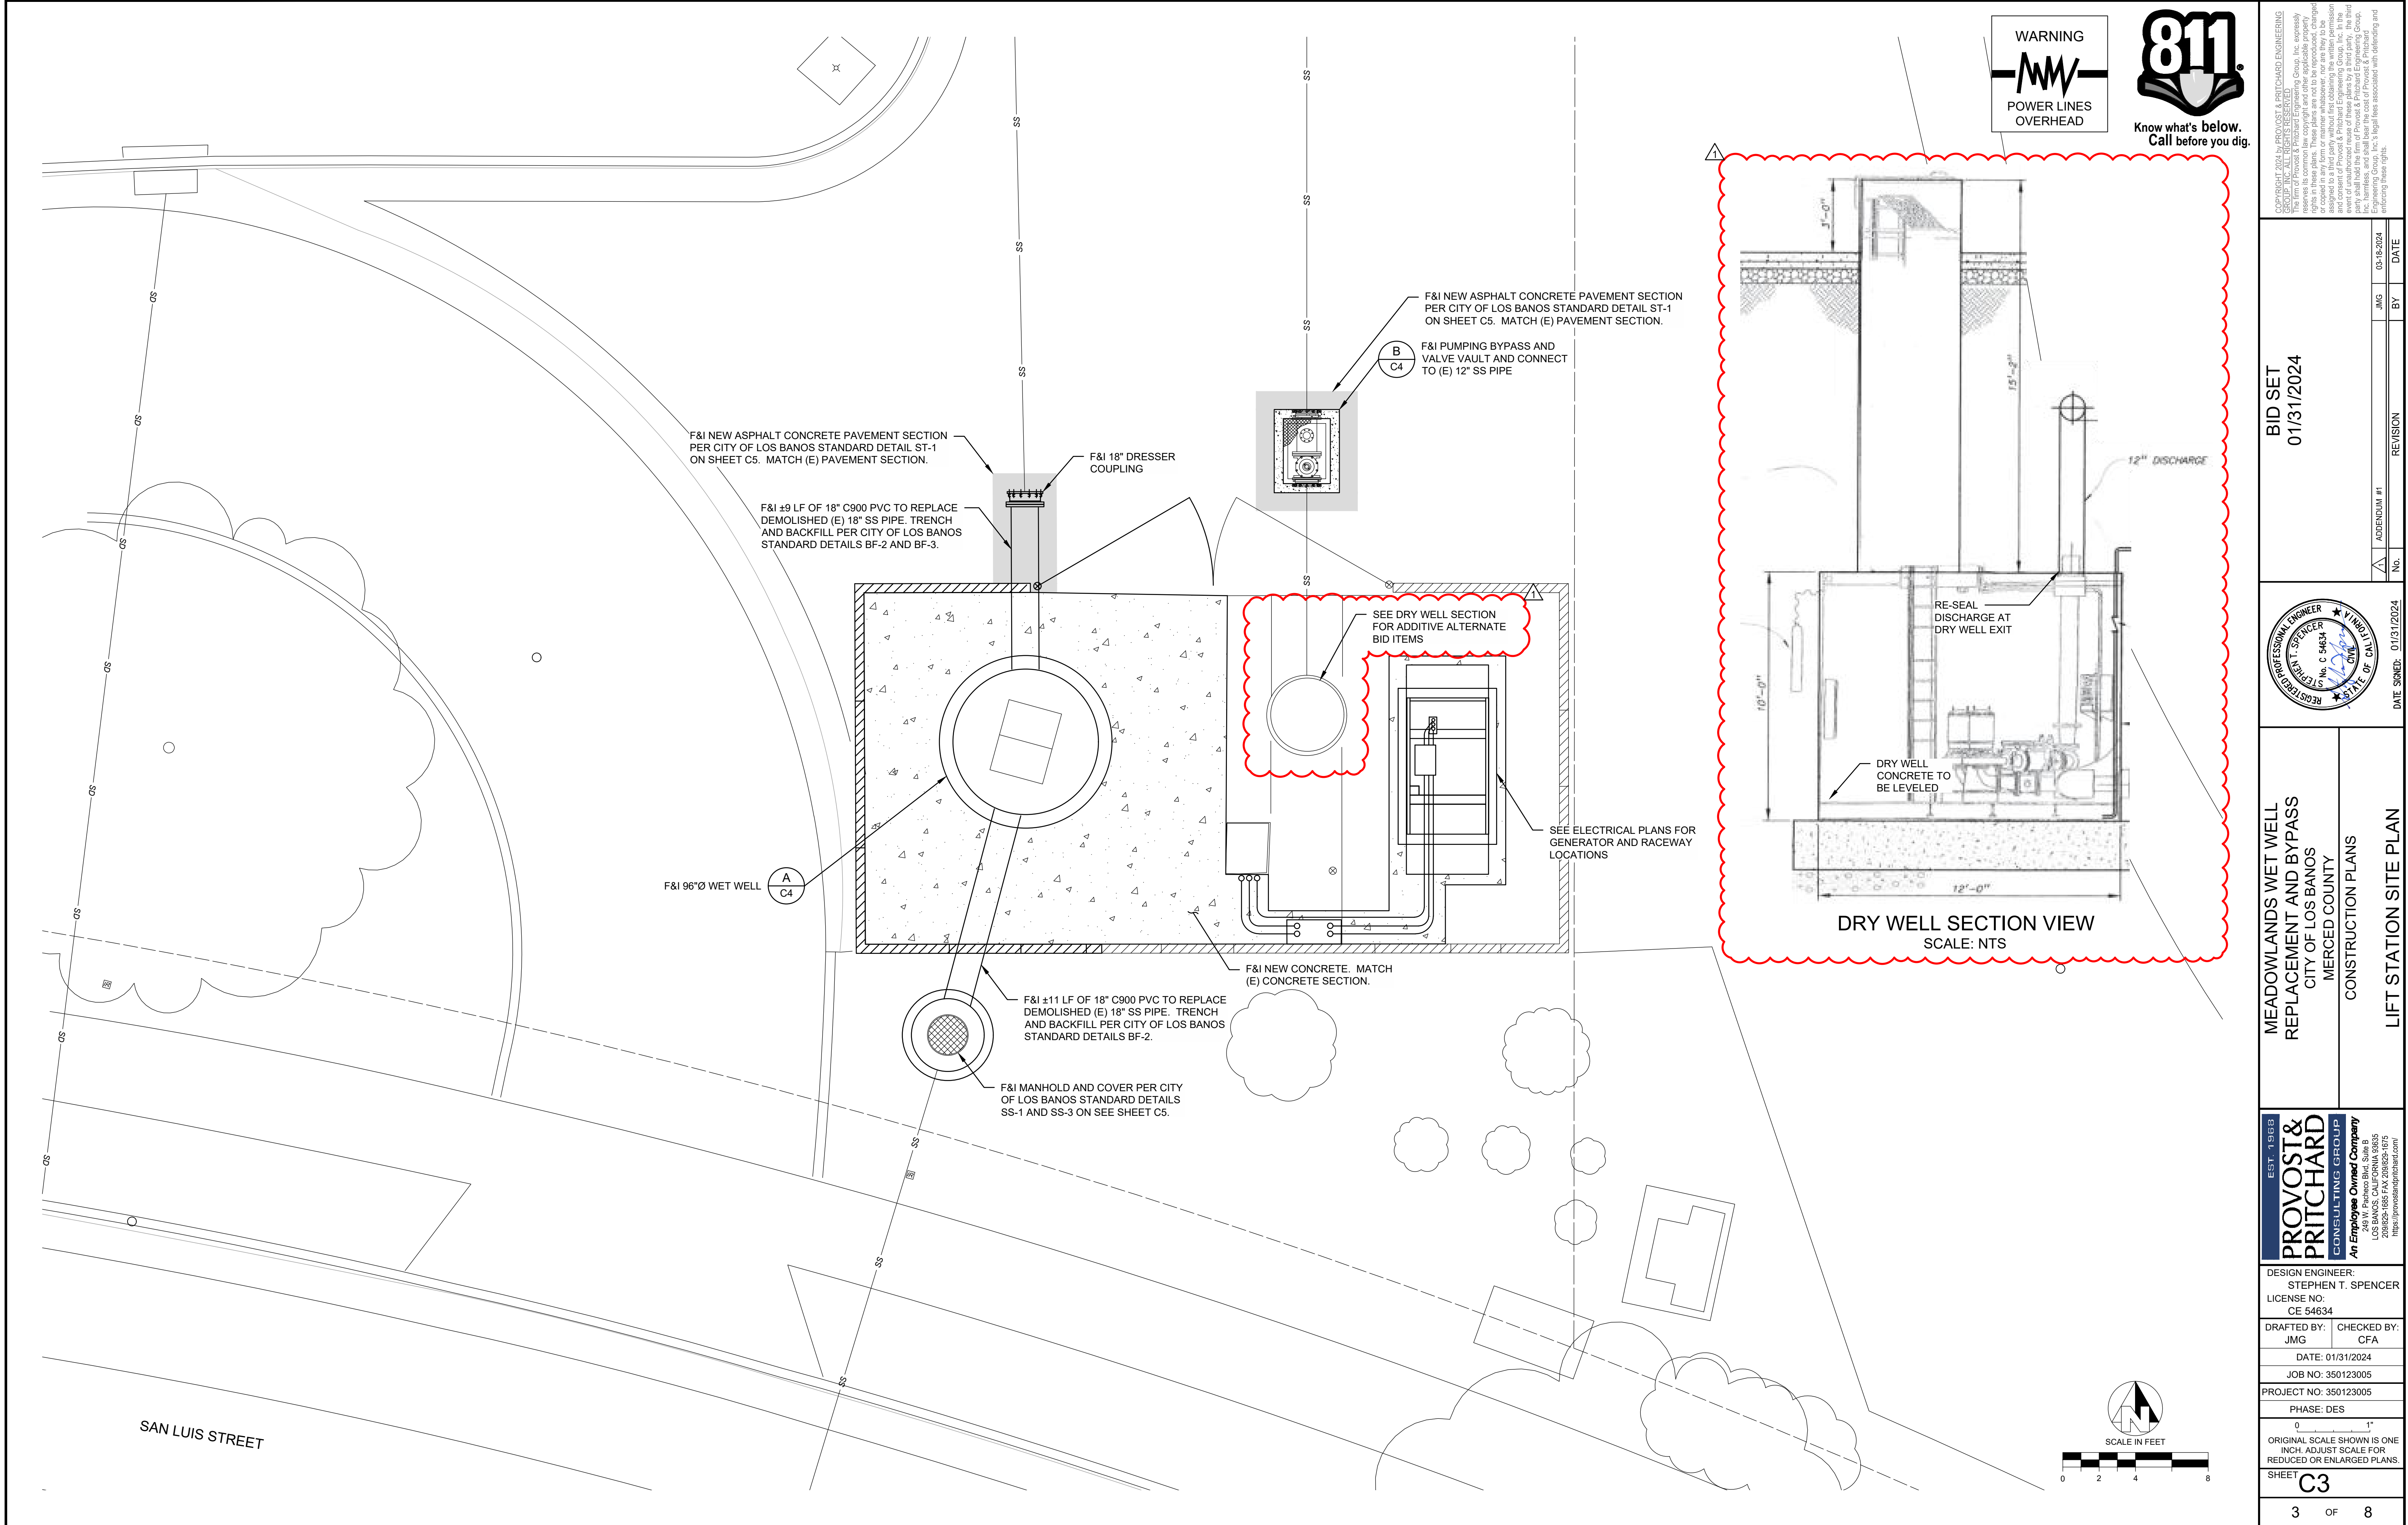


WARNING
POWER LINES
OVERHEAD

811
Know what's below.
Call before you dig.

COPYRIGHT 2024 BY PROVOST & PRITCHARD ENGINEERING, INC. ALL RIGHTS RESERVED. THIS DOCUMENT IS THE PROPERTY OF PROVOST & PRITCHARD ENGINEERING, INC. AND IS NOT TO BE REPRODUCED, COPIED, OR TRANSMITTED IN ANY FORM OR BY ANY MEANS, ELECTRONIC OR MECHANICAL, INCLUDING PHOTOCOPYING, RECORDING, OR BY ANY INFORMATION STORAGE AND RETRIEVAL SYSTEM, WITHOUT THE WRITTEN PERMISSION OF PROVOST & PRITCHARD ENGINEERING, INC. THE USER OF THIS DOCUMENT AGREES TO HOLD PROVOST & PRITCHARD ENGINEERING, INC. HARMLESS FROM ANY AND ALL CLAIMS, DAMAGES, LOSSES, AND EXPENSES, INCLUDING ATTORNEY'S FEES, ARISING OUT OF OR RESULTING FROM THE USE OF THIS DOCUMENT. PROVOST & PRITCHARD ENGINEERING, INC. IS NOT RESPONSIBLE FOR ANY ERRORS OR OMISSIONS IN THIS DOCUMENT. THE USER SHALL HOLD THE FIRM OF PROVOST & PRITCHARD ENGINEERING, INC. HARMLESS FROM ANY AND ALL CLAIMS, DAMAGES, LOSSES, AND EXPENSES, INCLUDING ATTORNEY'S FEES, ARISING OUT OF OR RESULTING FROM THE USE OF THIS DOCUMENT.

ADDENDUM #1	NO.	REVISION	BY	DATE
			JMG	03-18-2024

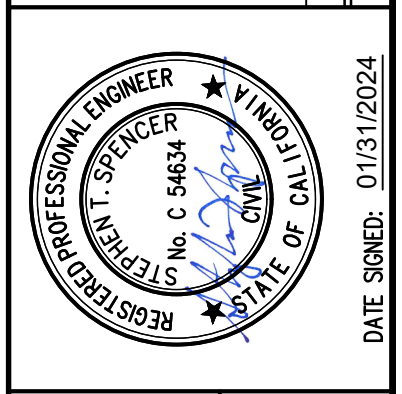


**MEADOWLANDS WET WELL
REPLACEMENT AND BYPASS**
CITY OF LOS BANOS
MERCED COUNTY
CONSTRUCTION PLANS


LIFT STATION SITE PLAN

PROVOST & PRITCHARD CONSULTING GROUP EST. 1968 An Employee Owned Company 200 W. Peches Rd., Suite B LOS BANOS, CALIFORNIA 93655 209/829-1895 FAX 209/829-1875 www.provostandpritchard.com
DESIGN ENGINEER: STEPHEN T. SPENCER LICENSE NO: CE 54634
DRAFTED BY: JMG
CHECKED BY: CFA
DATE: 01/31/2024
JOB NO: 350123005
PROJECT NO: 350123005
PHASE: DES
ORIGINAL SCALE SHOWN IS ONE INCH. ADJUST SCALE FOR REDUCED OR ENLARGED PLANS.
SHEET C3
3 OF 8


03/08/24 11:06:25 AM F:\23\021 CITY OF LOS BANOS MEADOWLANDS LIFT STATION\ENGR\SHEETS\021_E2.0 DETAILS.DWG cmendez

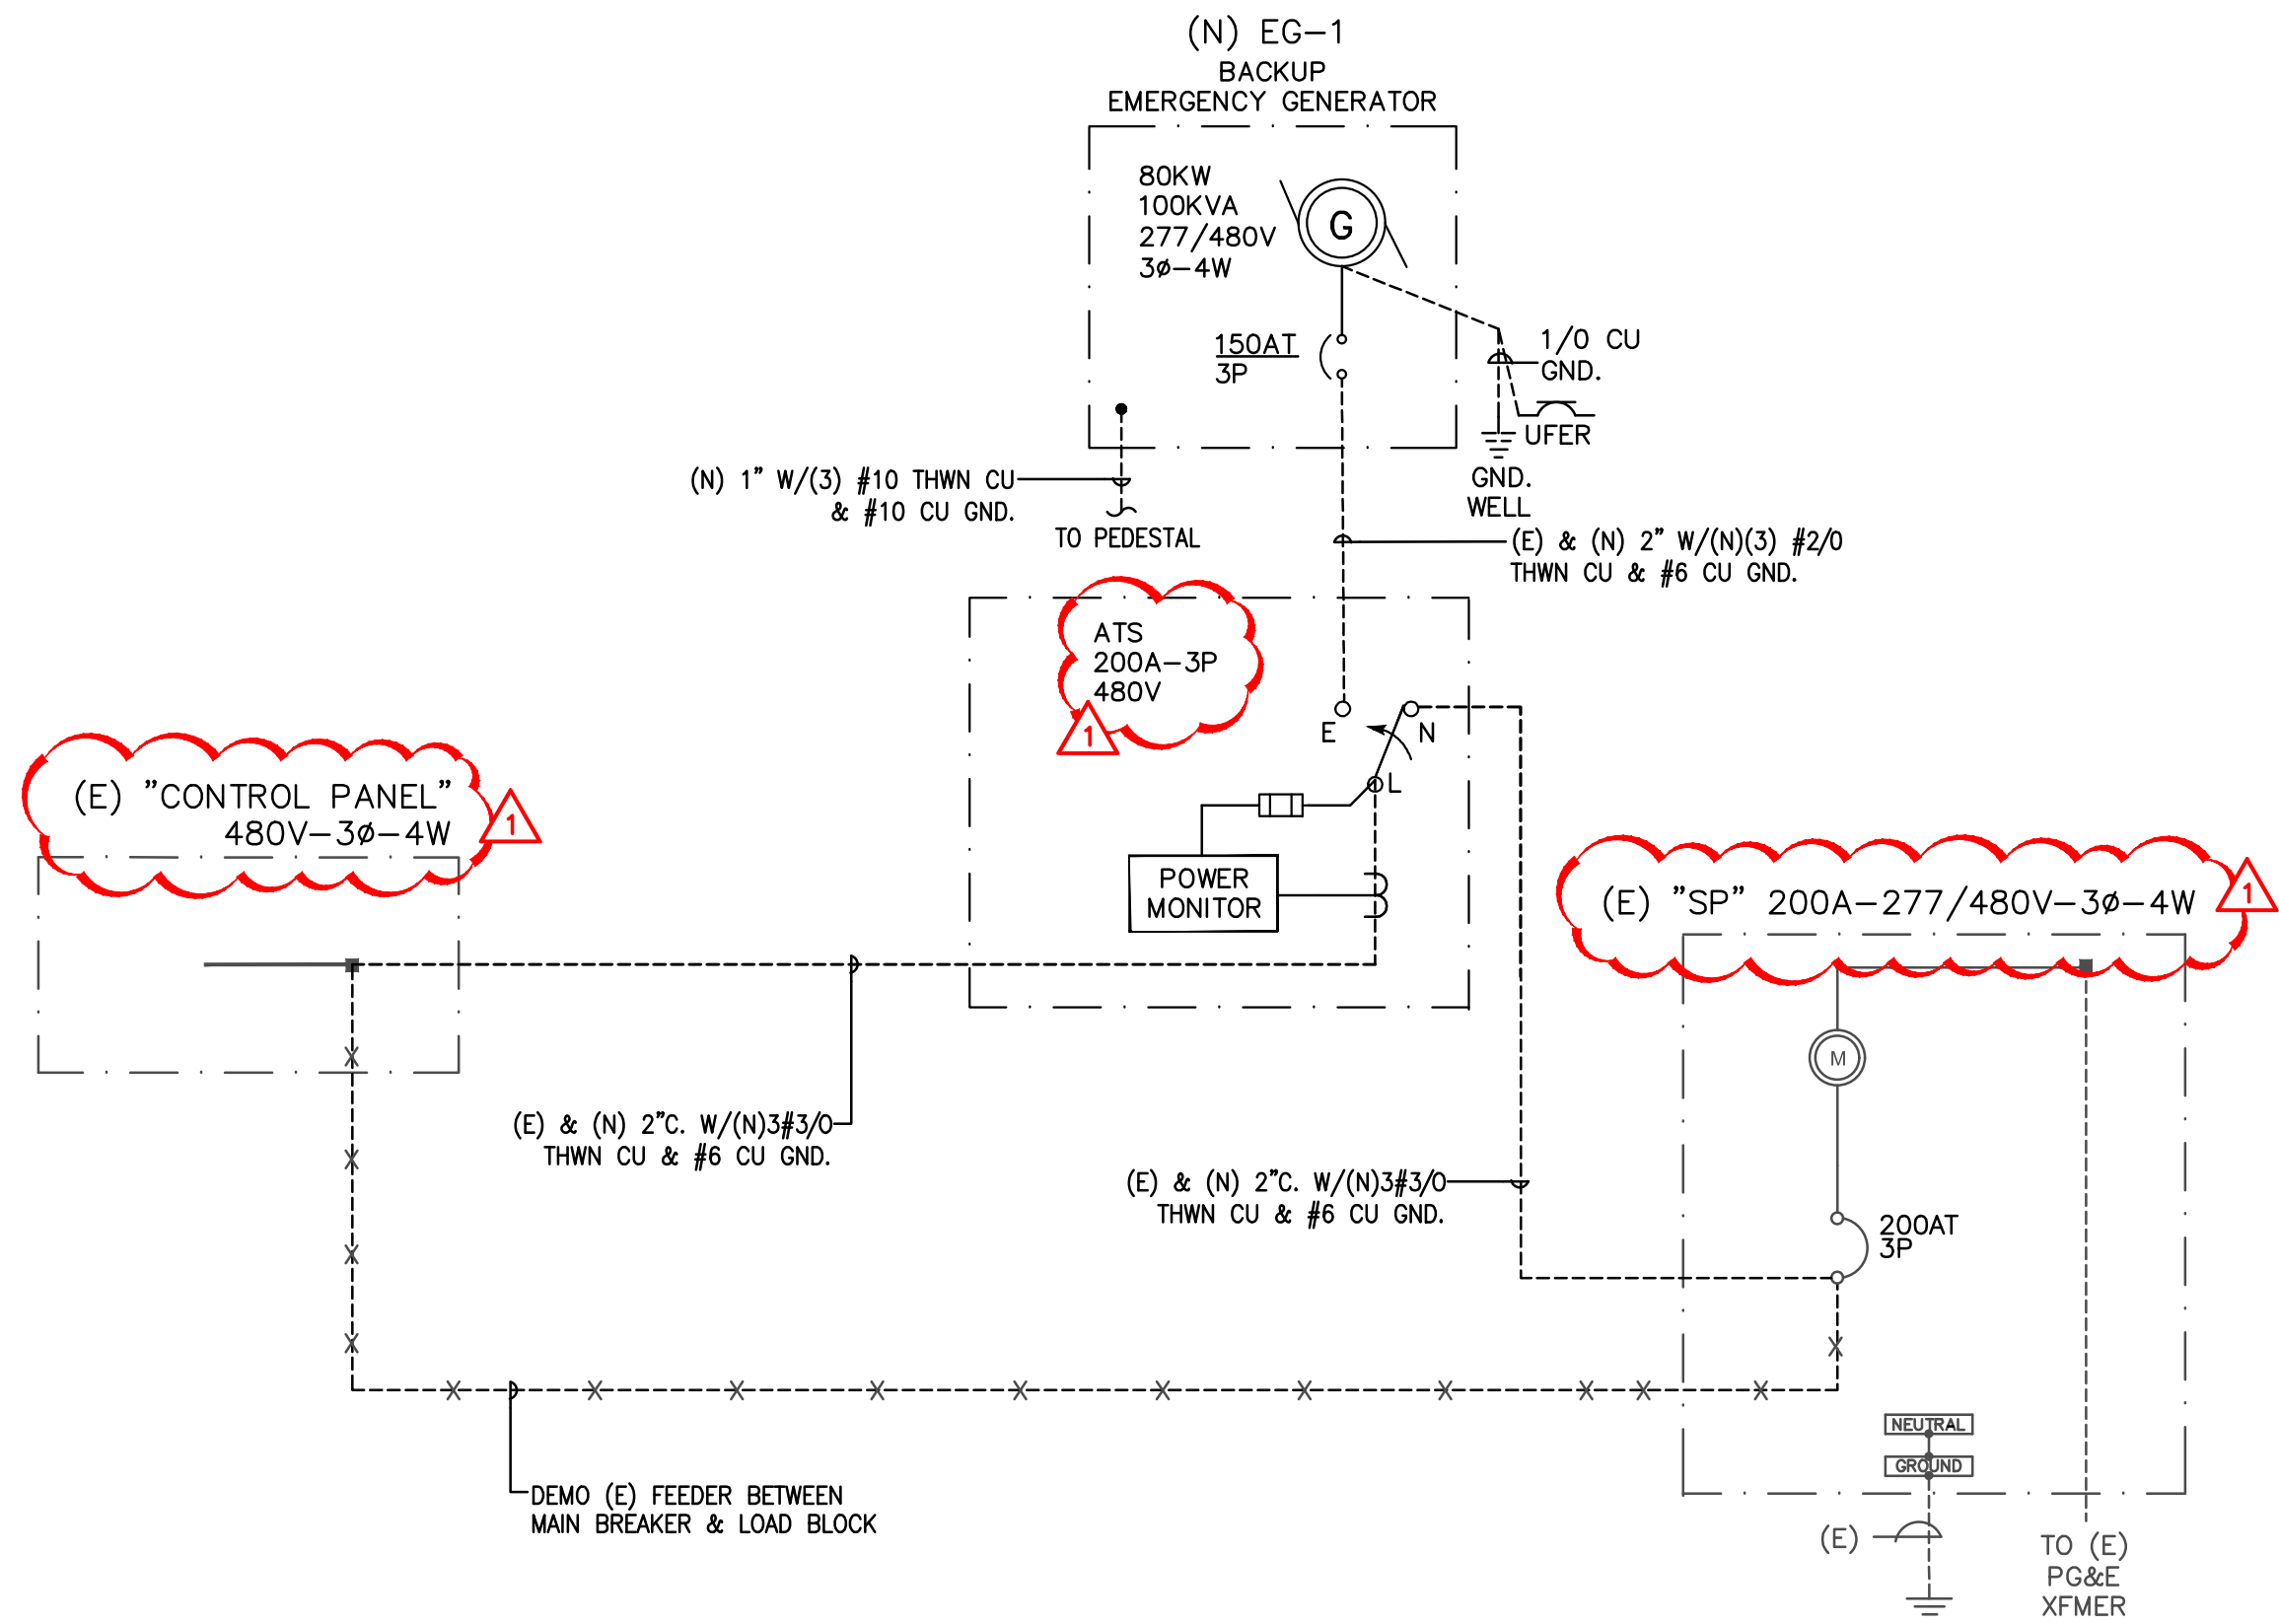

1 SINGLE LINE DIAGRAM
SCALE: NTS

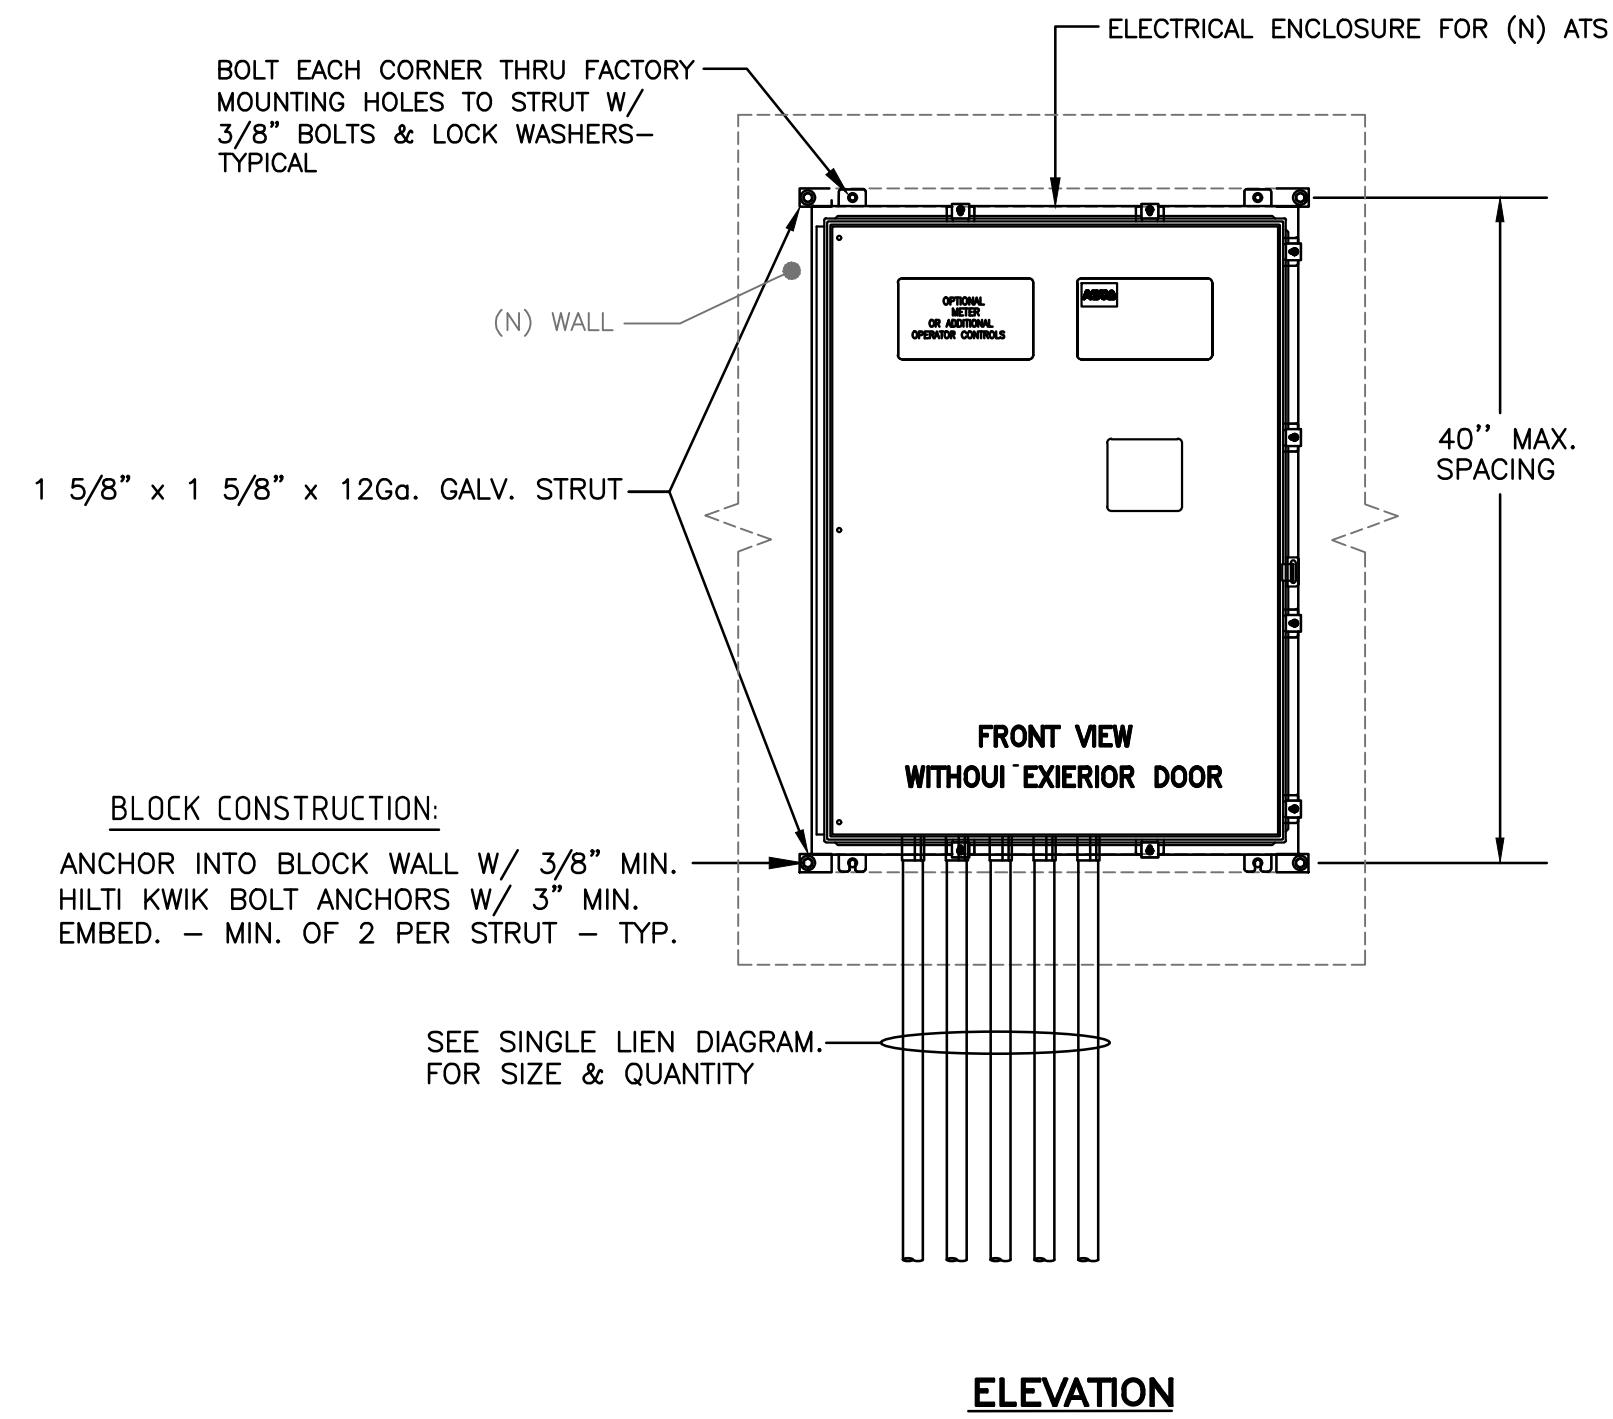


2 SURFACE PANEL MOUNTING DETAIL
SCALE: NTS

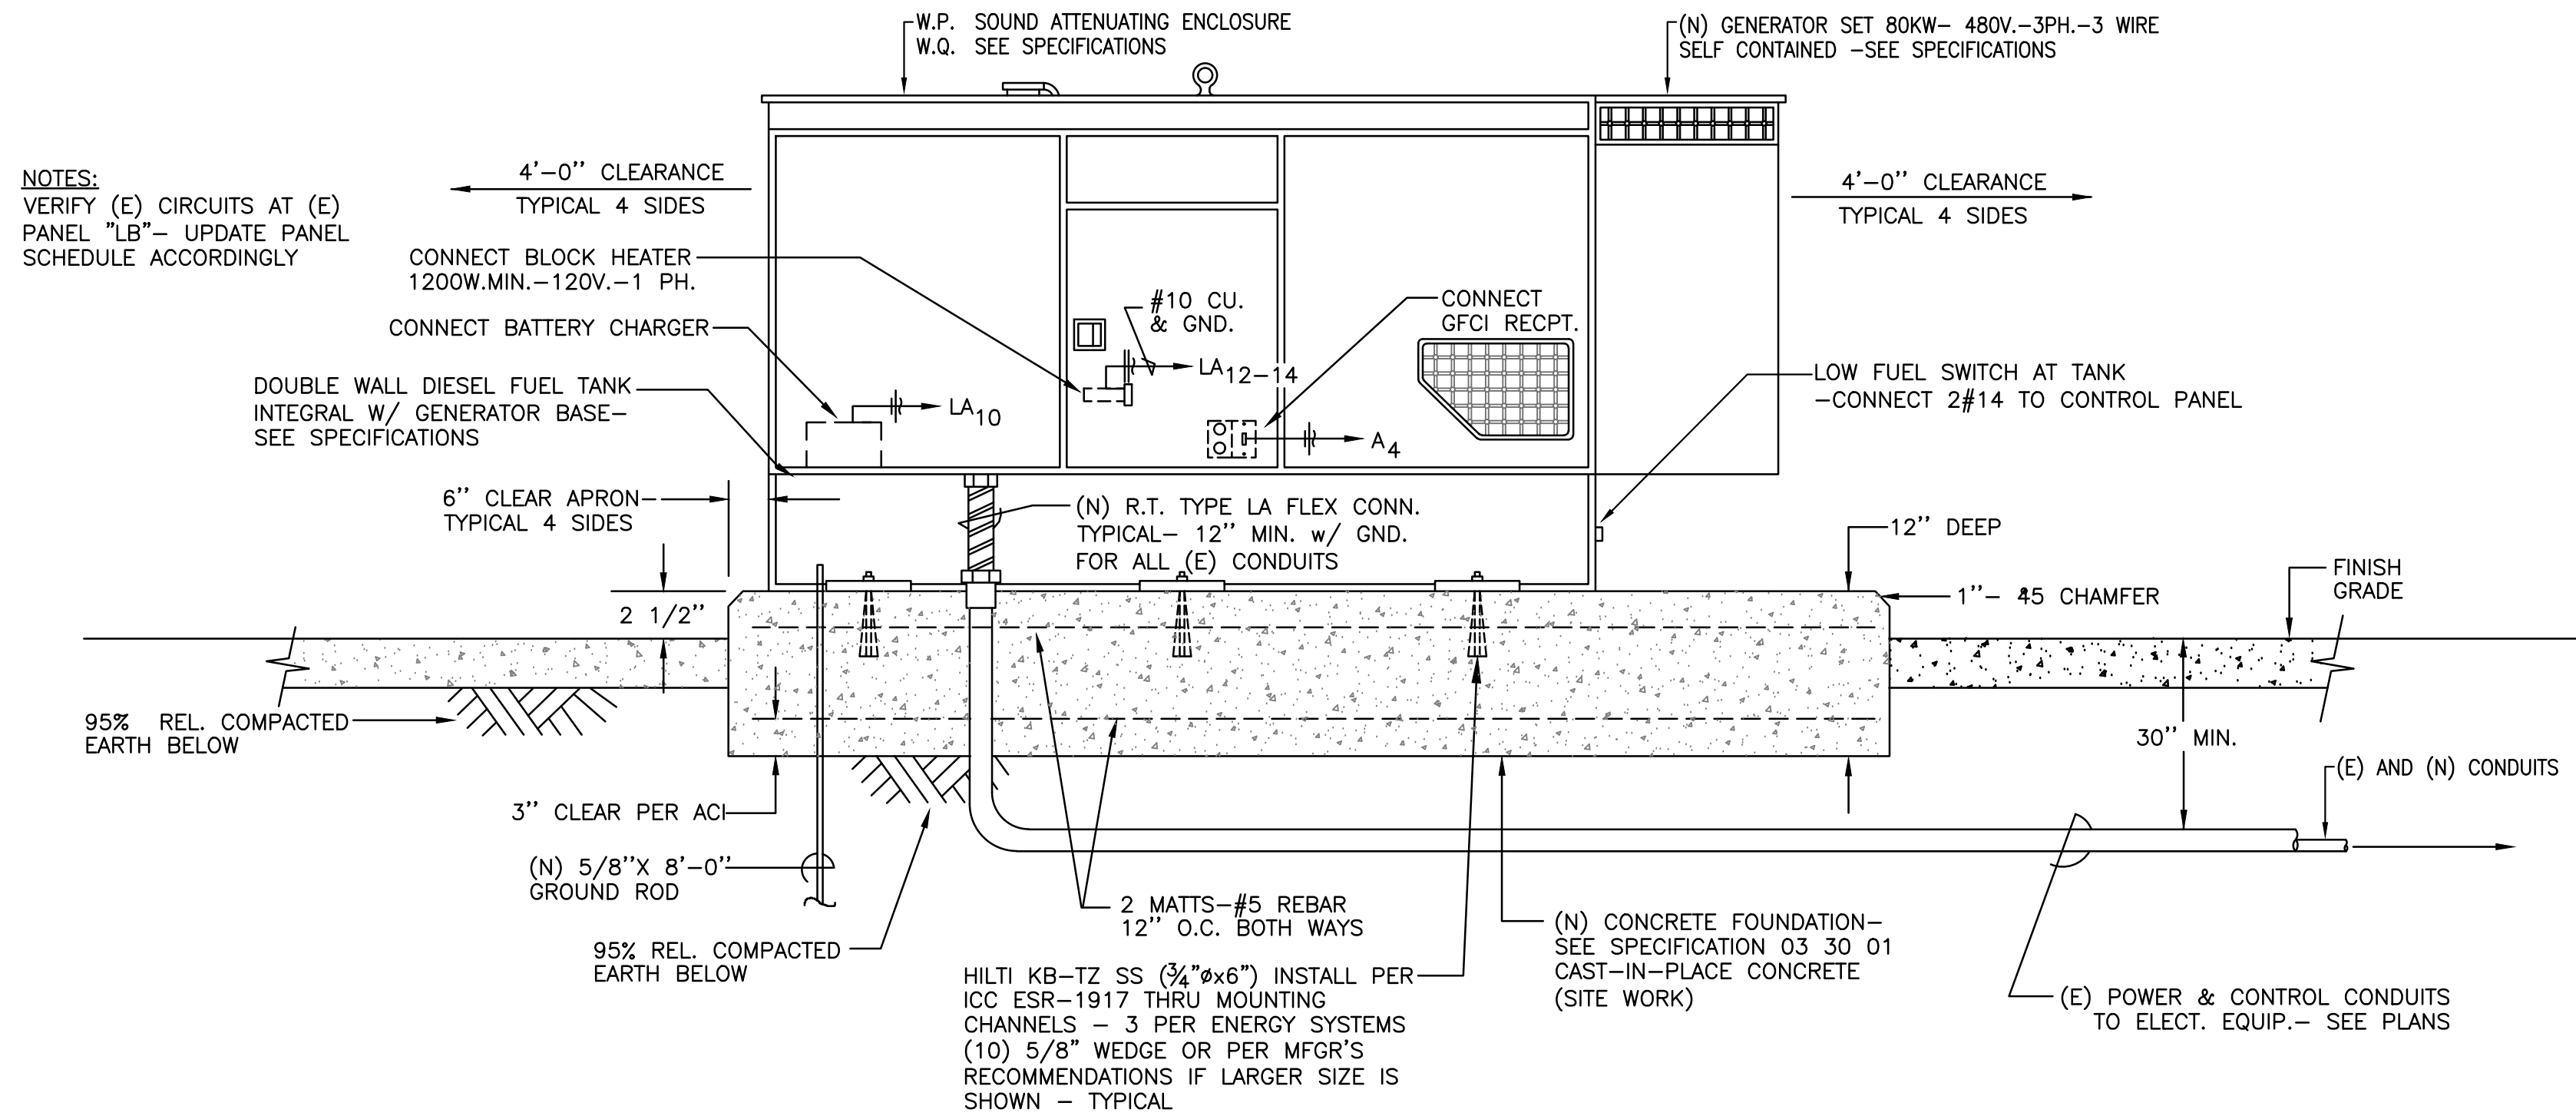


SECTION

3 NEW GEN-SET AND FOUNDATION
SCALE: NTS

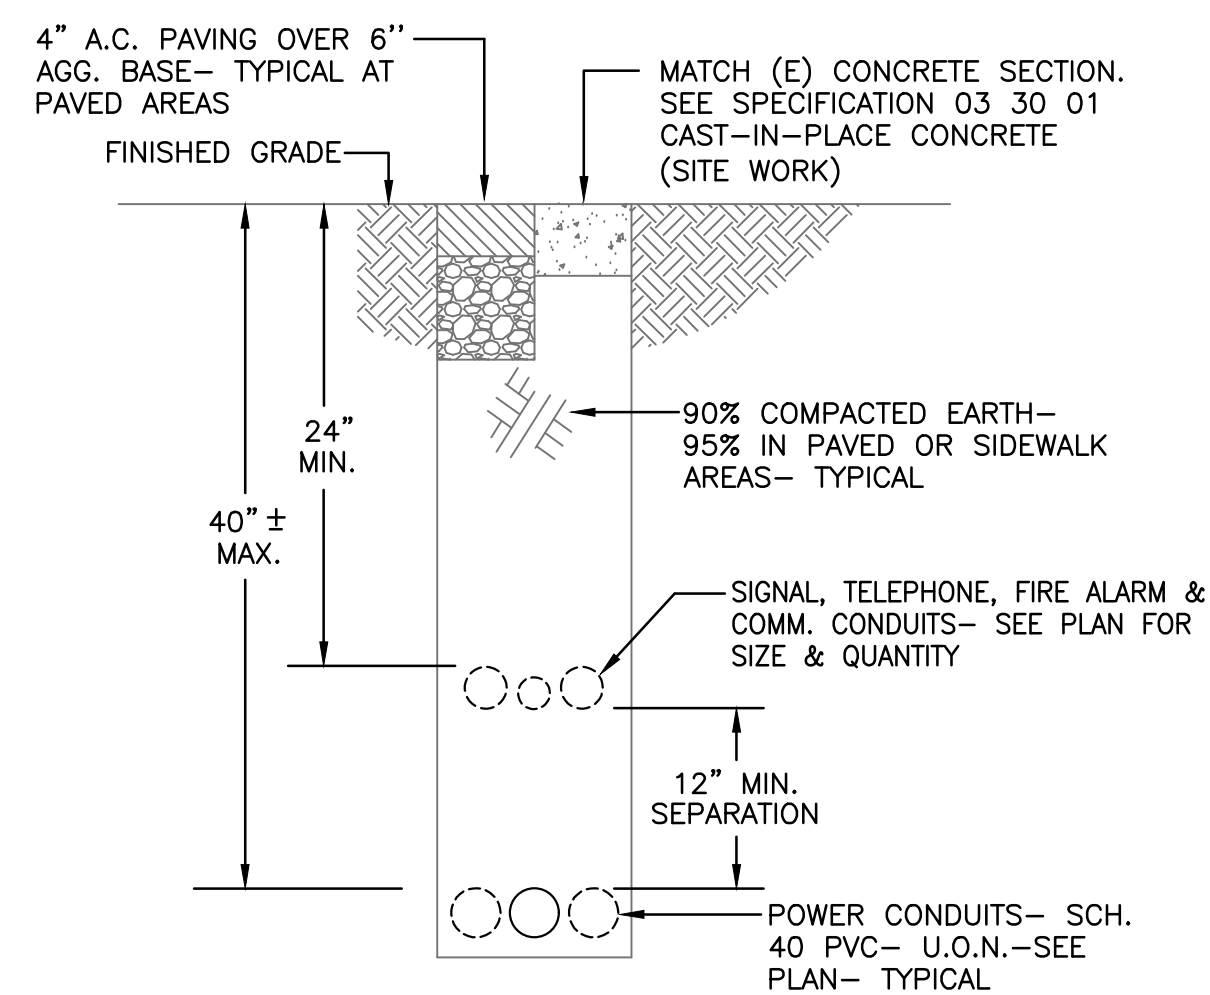

4 ELECTRICAL TRENCH SECTION (TYP.)
SCALE: NTS


PEZZONI ENGINEERING, INC.
CONSULTING ELECTRICAL ENGINEERS
1150 9TH Street, Suite #1415 Modesto, CA 95354
PHONE: 209-554-4602
HTTP://WWW.PEZZENGR.COM
PEZZONI ENGINEERING, INC. © Copyrighted 2024

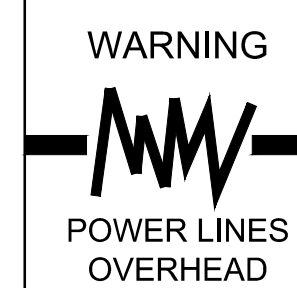

COPYRIGHT 2024 BY PROVOST & PRITCHARD ENGINEERING GROUP, INC. ALL RIGHTS RESERVED. This document is the property of Provost & Pritchard Engineering Group, Inc. and is not to be reproduced, stored in a retrieval system, or transmitted in any form or by any means, electronic, mechanical, photocopying, recording, or by any information storage and retrieval system, without the prior written permission of Provost & Pritchard Engineering Group, Inc. The user of this document acknowledges that the user is not a party to the contract between Provost & Pritchard Engineering Group, Inc. and the City of Los Banos, and that the user is not to be held responsible for any errors or omissions in this document.

1	No.	REVISION	BY	DATE
		ADDENDUM #1		

BID SET
01/31/2024

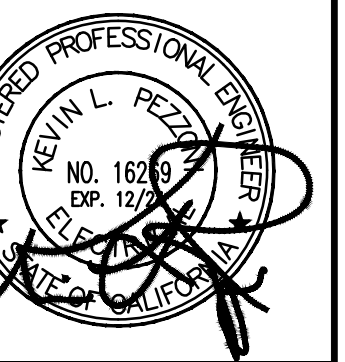

MEADOWLANDS WET WELL
REPLACEMENT AND BYPASS
CITY OF LOS BANOS
MERCED COUNTY
ELECTRICAL PLANS
DETAILS

EST. 1958
PROVOST & PRITCHARD
CONSULTING GROUP
An Employee Owned Company
LOS BANOS, CALIFORNIA 93855
208826-085 FAX 208826-1675
http://www.provostpritchard.com

DESIGN ENGINEER:
Kevin Pezzoni
LICENSE NO.:
16269

DRAFTED BY:
CCM
CHECKED BY:
KP

DATE: 01/31/2024

JOB NO: 350123005

PROJECT NO: 350123005

PHASE: DES

ORIGINAL SCALE SHOWN IS ONE INCH. ADJUST SCALE FOR REDUCED OR ENLARGED PLANS.
SHEET
E2.1

8 OF 8

03/08/24 11:06:25 AM F:\23\021 CITY OF LOS BANOS MEADOWLANDS LIFT STATION\ENGR\SHEETS\021_E2.0 DETAILS.DWG cmendez