



ADDENDUM NO. 1
March 18, 2024

NORTHGATE SEWER LIFT STATION EMERGENCY POWER IMPROVEMENTS

ITEM NO. 1:

SHEET E2.1 OF PLANSET

Drawing E2.1 has updates to amperage and voltage shown in the single line diagram.

ITEM NO. 2:

RESPONSE TO QUESTIONS & CLARIFICATIONS

1. Would the City of Los Banos have objection to moving the ATS onto pipe supports on the side of the existing pump control pedestal.

Response: The City of Los Banos would like for bids to be based on project plans.

2. It was noticed that there is a requirement for the prime bidder to have a Class A license. Given that this project is a prime electrical project, would a Class B or C-10 license be sufficient?

Response: A Class B or C10 license is acceptable.

3. Is there an engineer's estimate for the project?

Response: The estimate for the project is \$270,000,000 to \$370,000.

This Addendum forms a part of the Proposal Documents and will be incorporated into the Contract Documents, as applicable. All other conditions of the Contract Documents remain unchanged. The following changes, additions, or deletions as set forth herein shall apply to the Contract Documents and shall be made a part thereof and shall be subject to all the requirements thereof as through originally shown and/or specified.

 
Proposals shall be submitted in accordance with this Addendum. All consultants **MUST** acknowledge receipt of this Addendum by signing and returning this Addendum with your Proposal.

(Signatures on following page)


City of Los Banos
Public Works Department
411 Madison Ave. Los Banos, CA 93635

Addendum No. 1


City of Los Banos


By: Jelene de Melo
Admin Coordinator


Firm Name: _____
By: _____
Title: _____
Date: _____

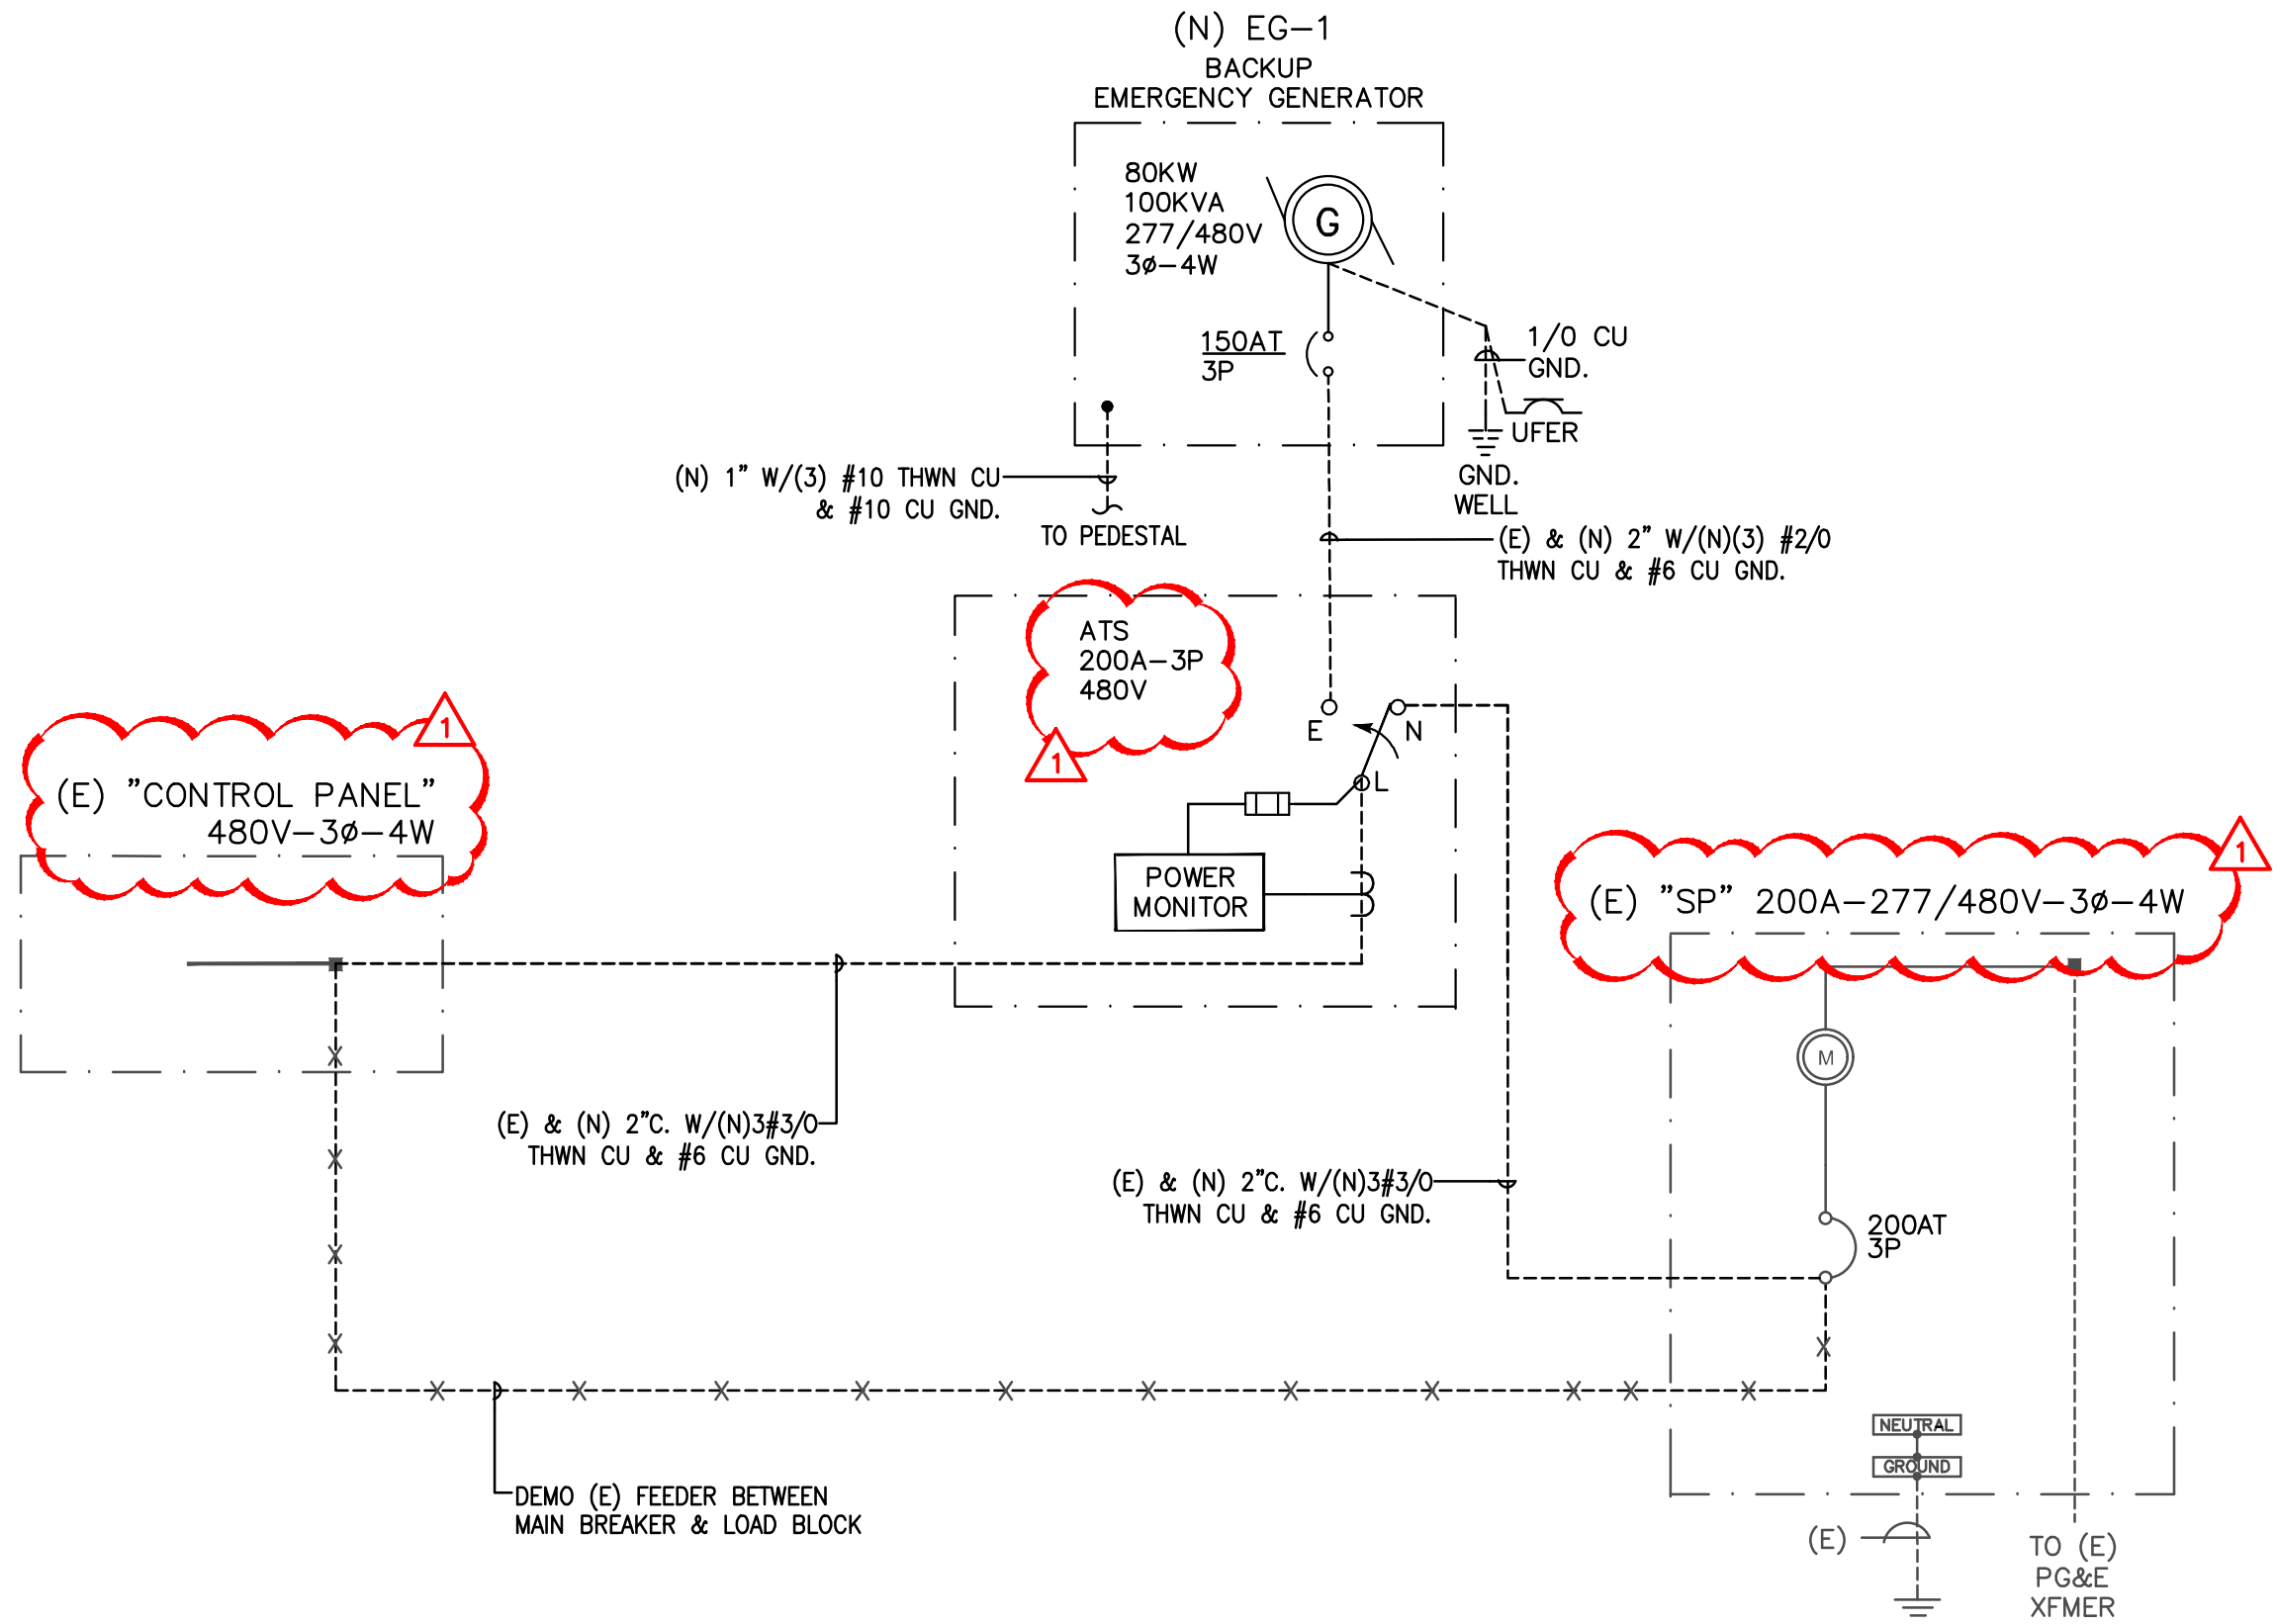


1 SINGLE LINE DIAGRAM
SCALE: NTS

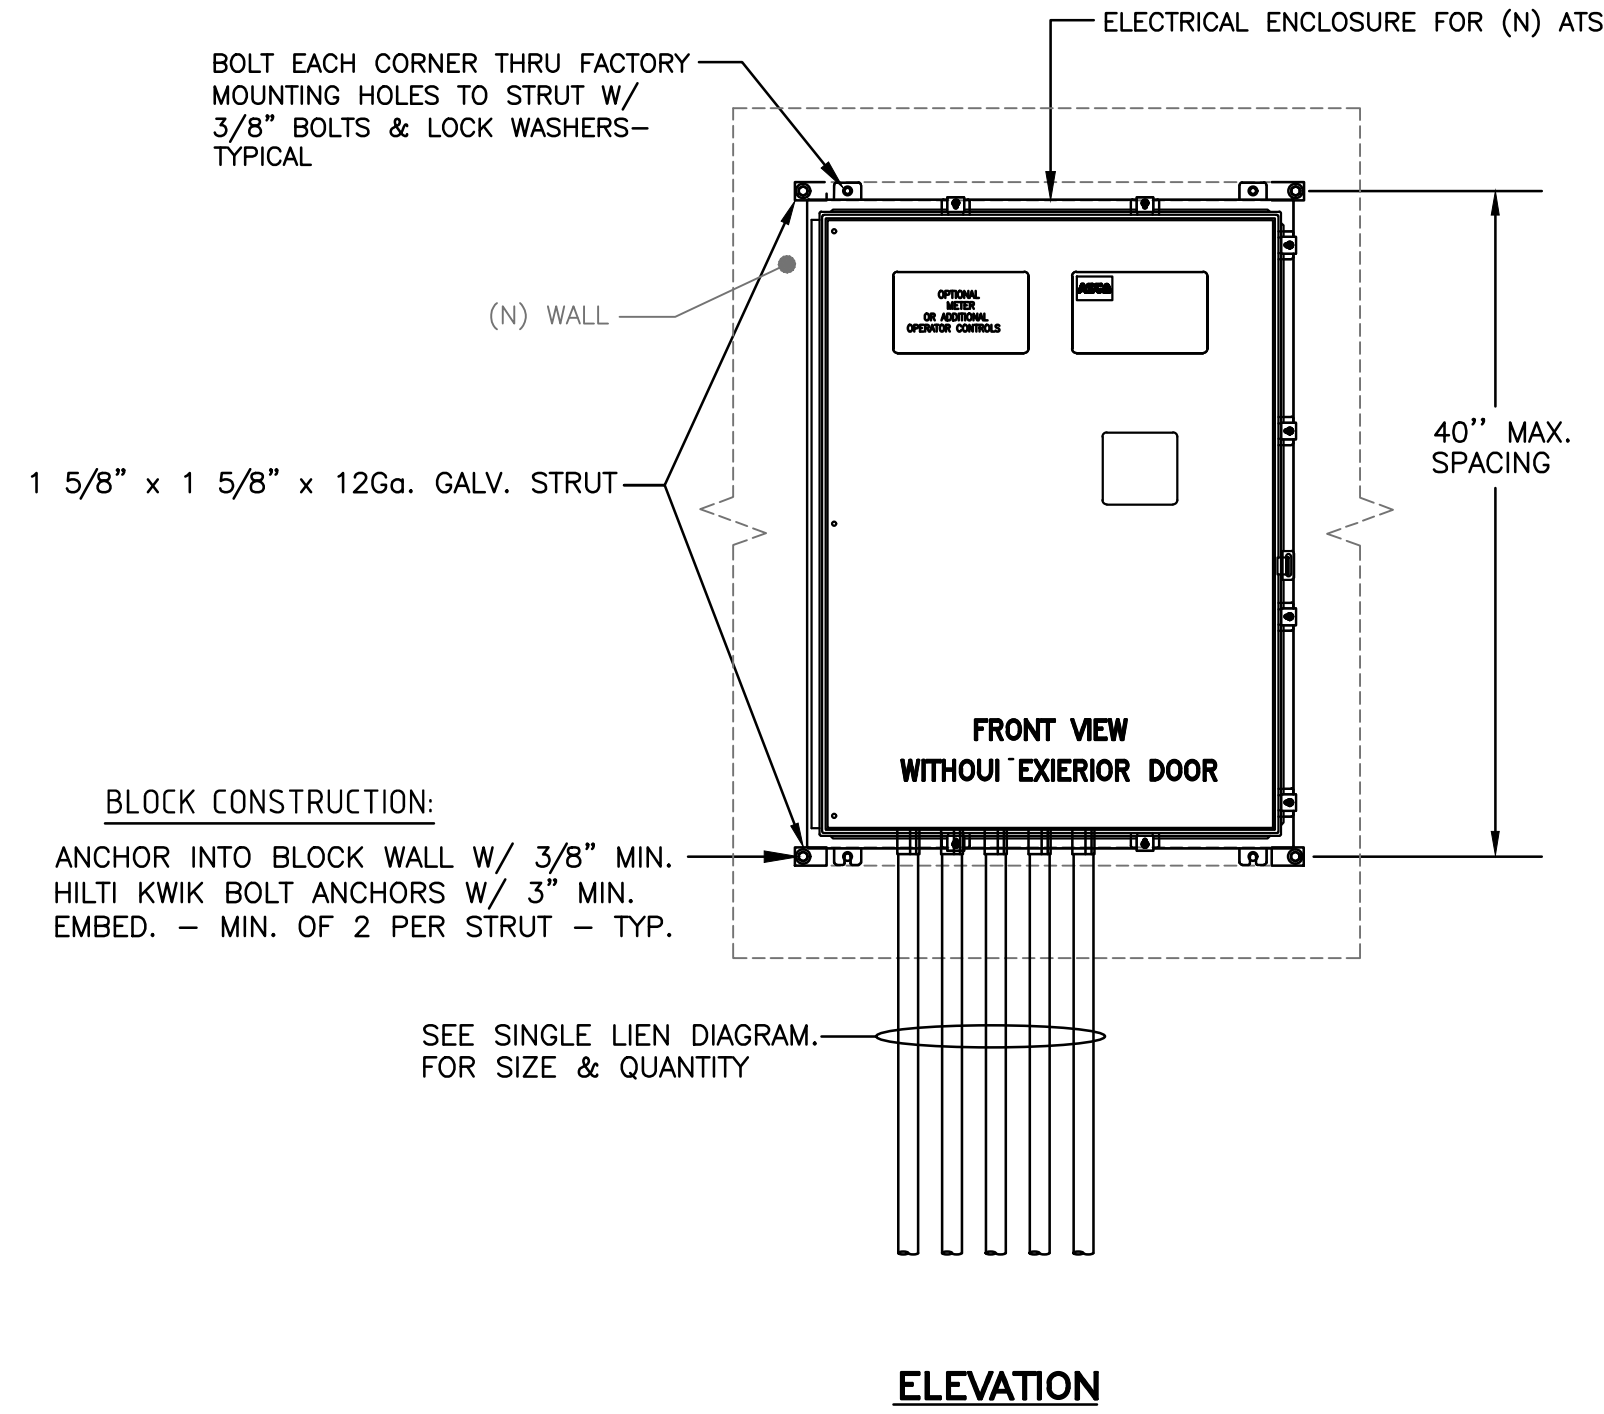


2 SURFACE PANEL MOUNTING DETAIL
SCALE: NTS

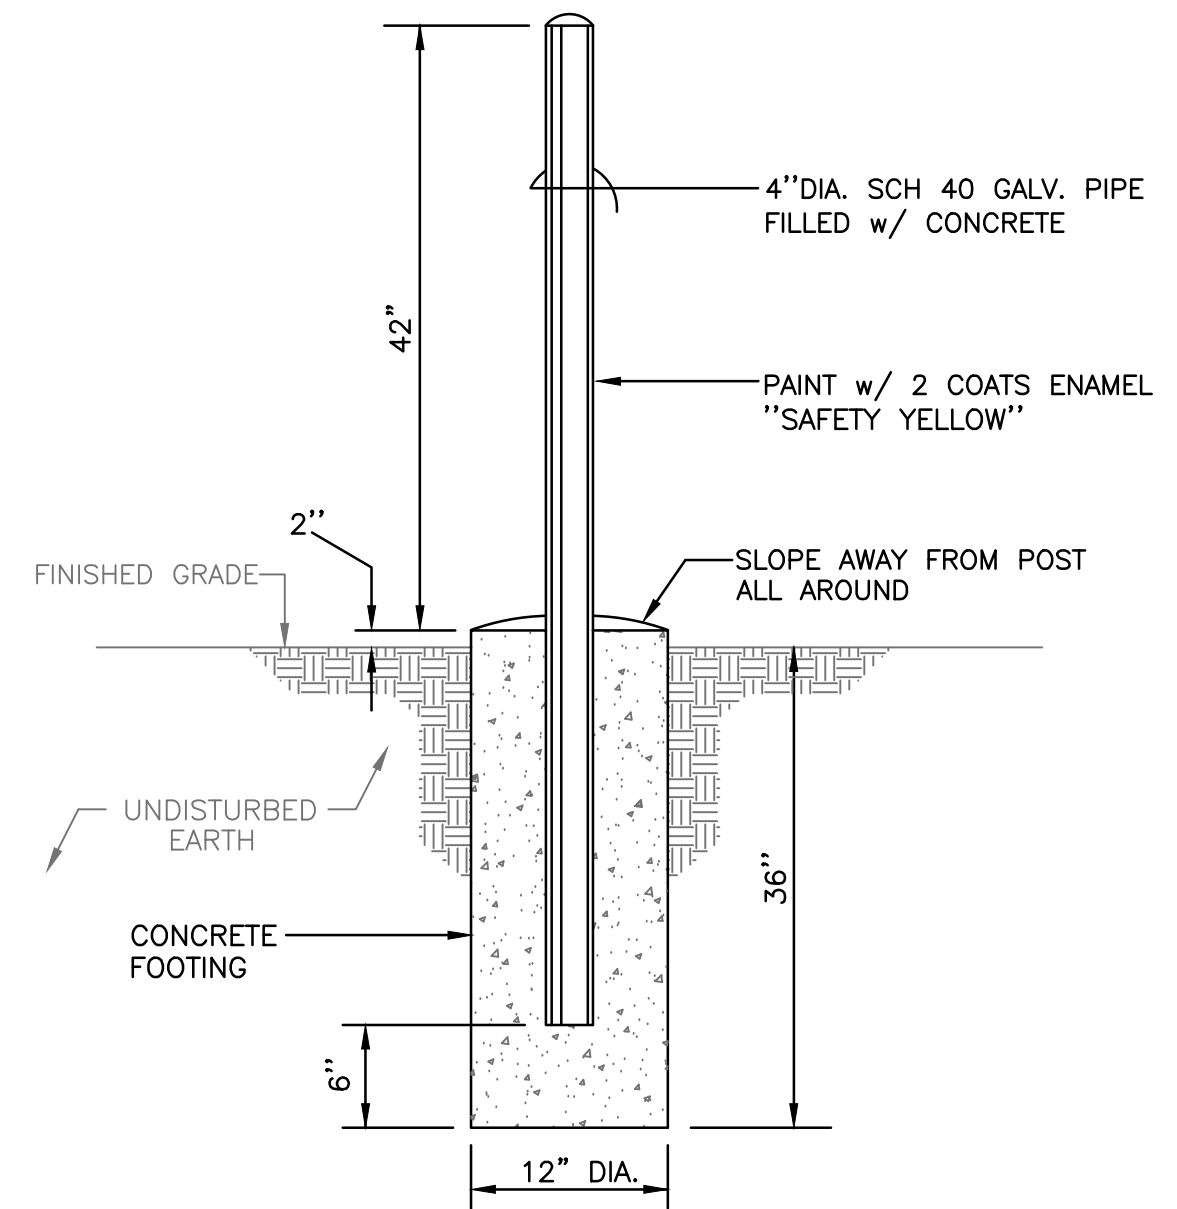

3 NON-REMOVABLE
GUARD POST
SCALE: NTS

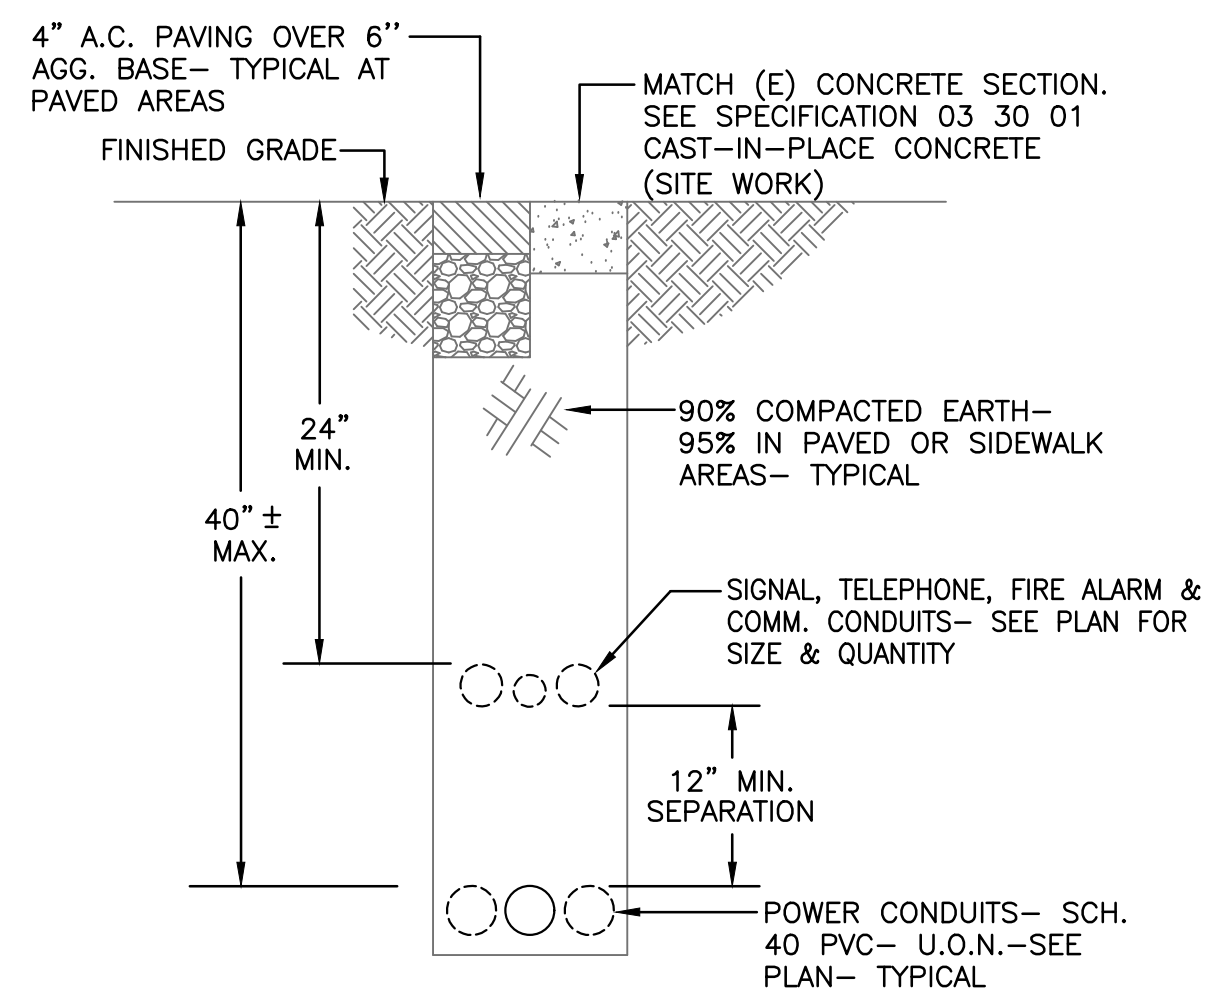

4 ELEC. TRENCH SECTION
SCALE: NTS

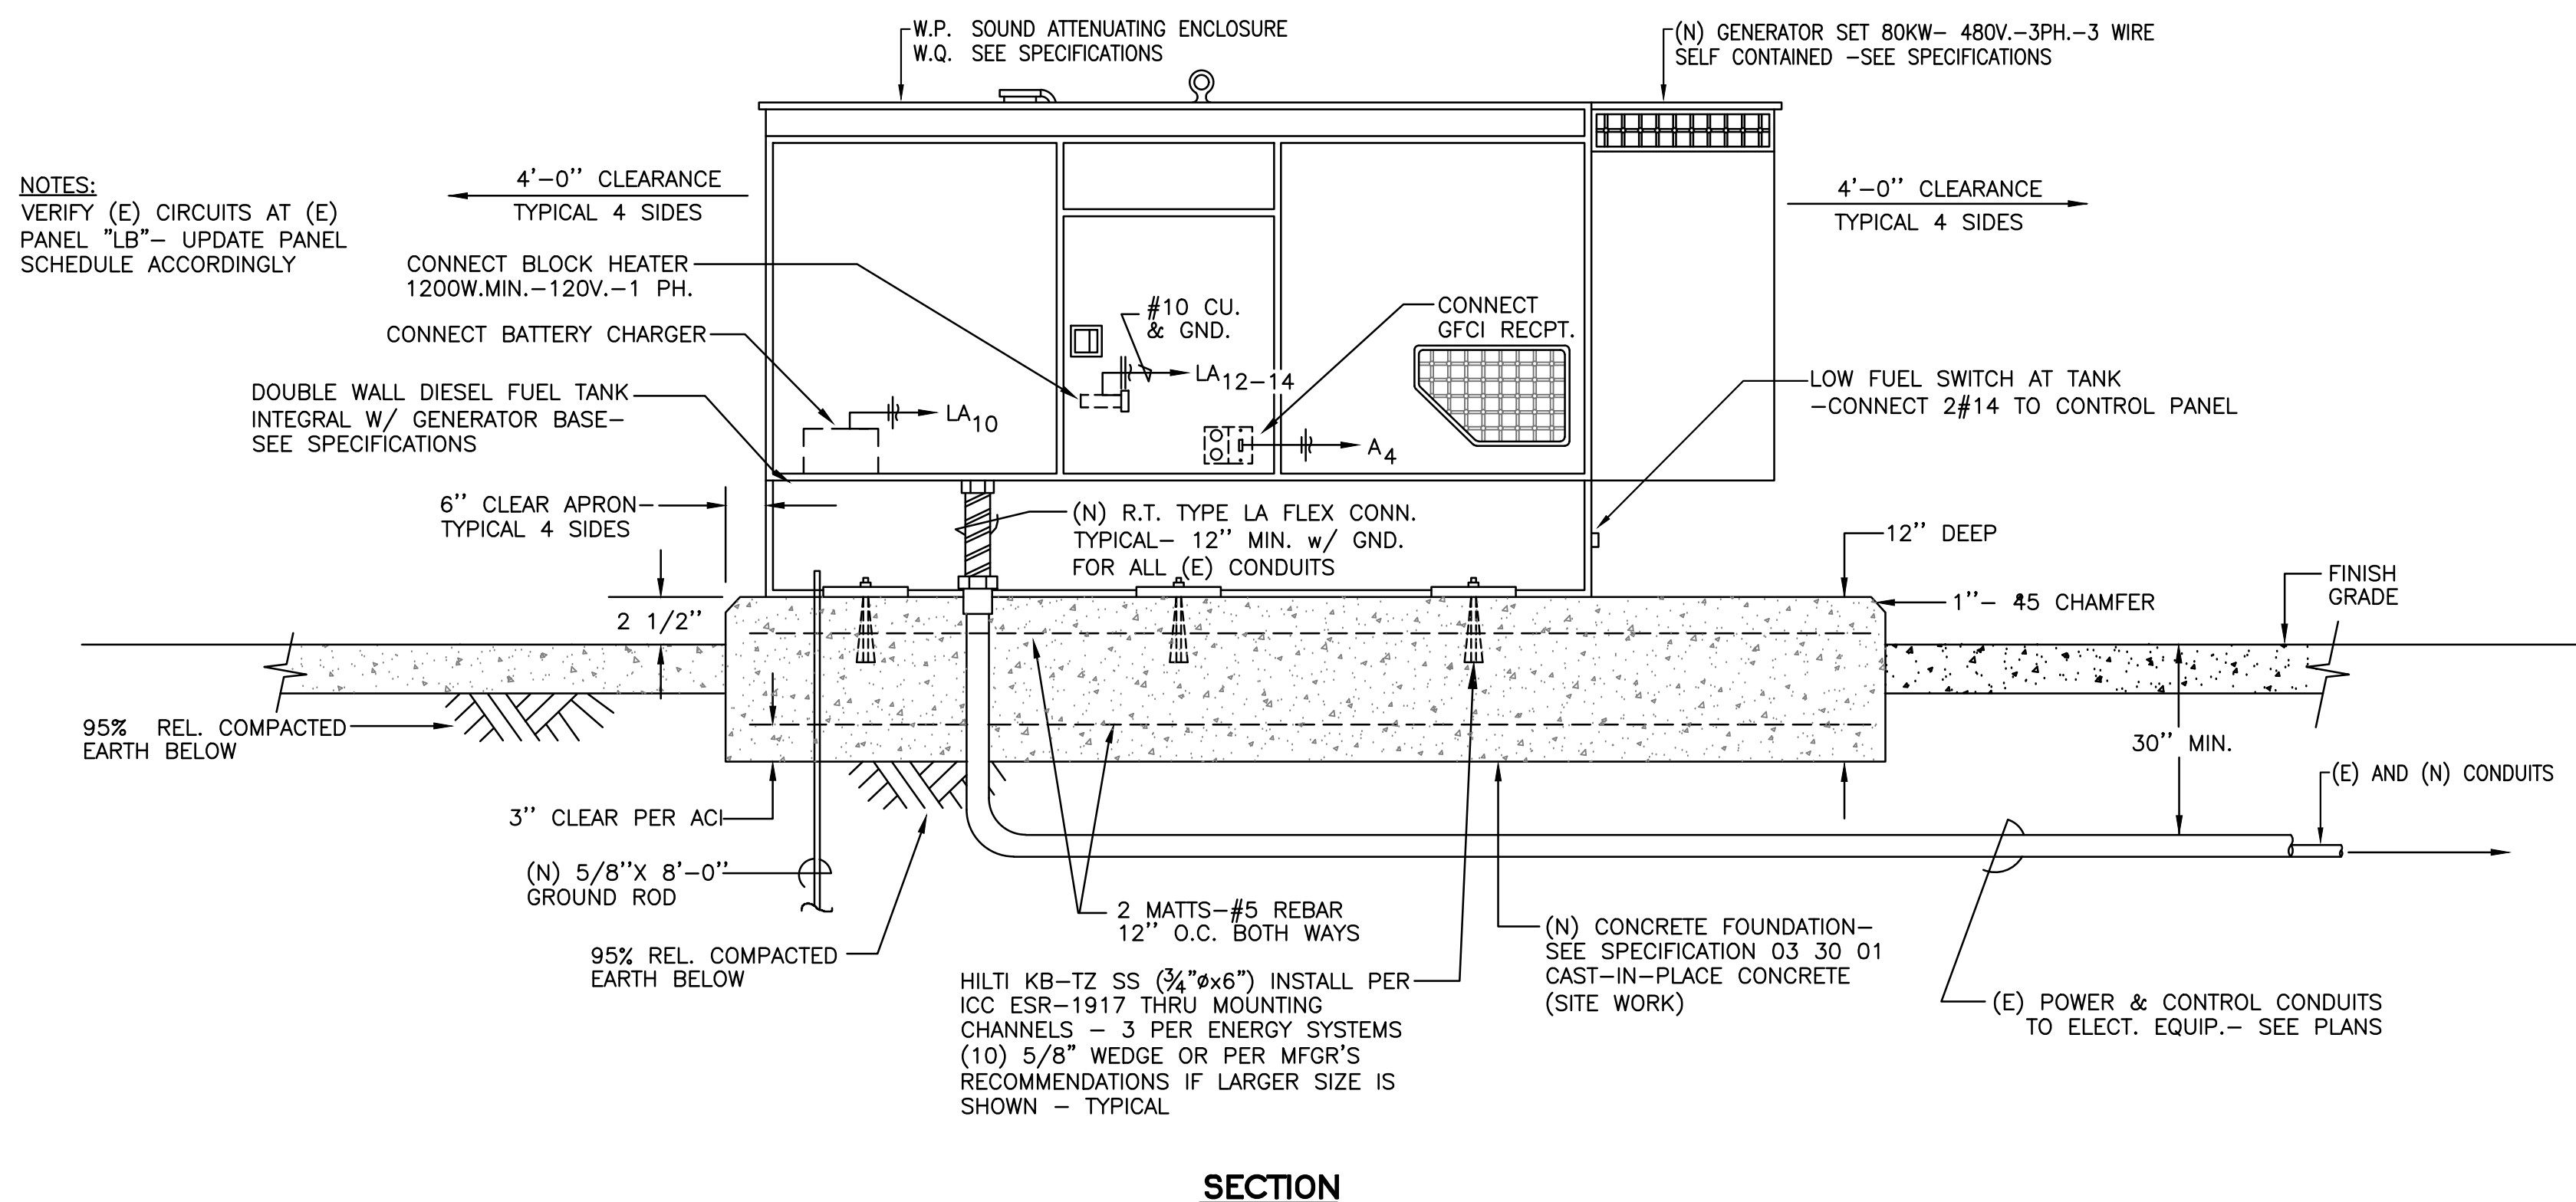

5 NEW GEN-SET AND FOUNDATION
SCALE: NTS



PEZZONI ENGINEERING, INC.
CONSULTING ELECTRICAL ENGINEERS
1150 9th Street, Suite #1415 Modesto, CA 95854
PHONE: 209.554.4602
HTTP://WWW.PEZZONER.COM

PEZZONI ENGINEERING, INC. © Copyrighted 2023

BID SET	
DATE:	01/31/2024
DRAWN:	CCM
CHECKED:	KP
REVISIONS:	BY
ADDENDUM #1 03/08/24	CCM

CLIENT

NORTHGATE SEWER LIFT STATION
EMERGENCY POWER IMPROVEMENTS
CITY OF LOS BANOS **MERCED COUNTY, CA**

PROJECT

23-944

SHEET TITLE

DETAILS

SHEET NO. --

E2.1